


MECHANICAL
ROOF
PLAN



DESIGNER: J. J. JENSEN
ARCHITECT
11/10/03

1/10/03

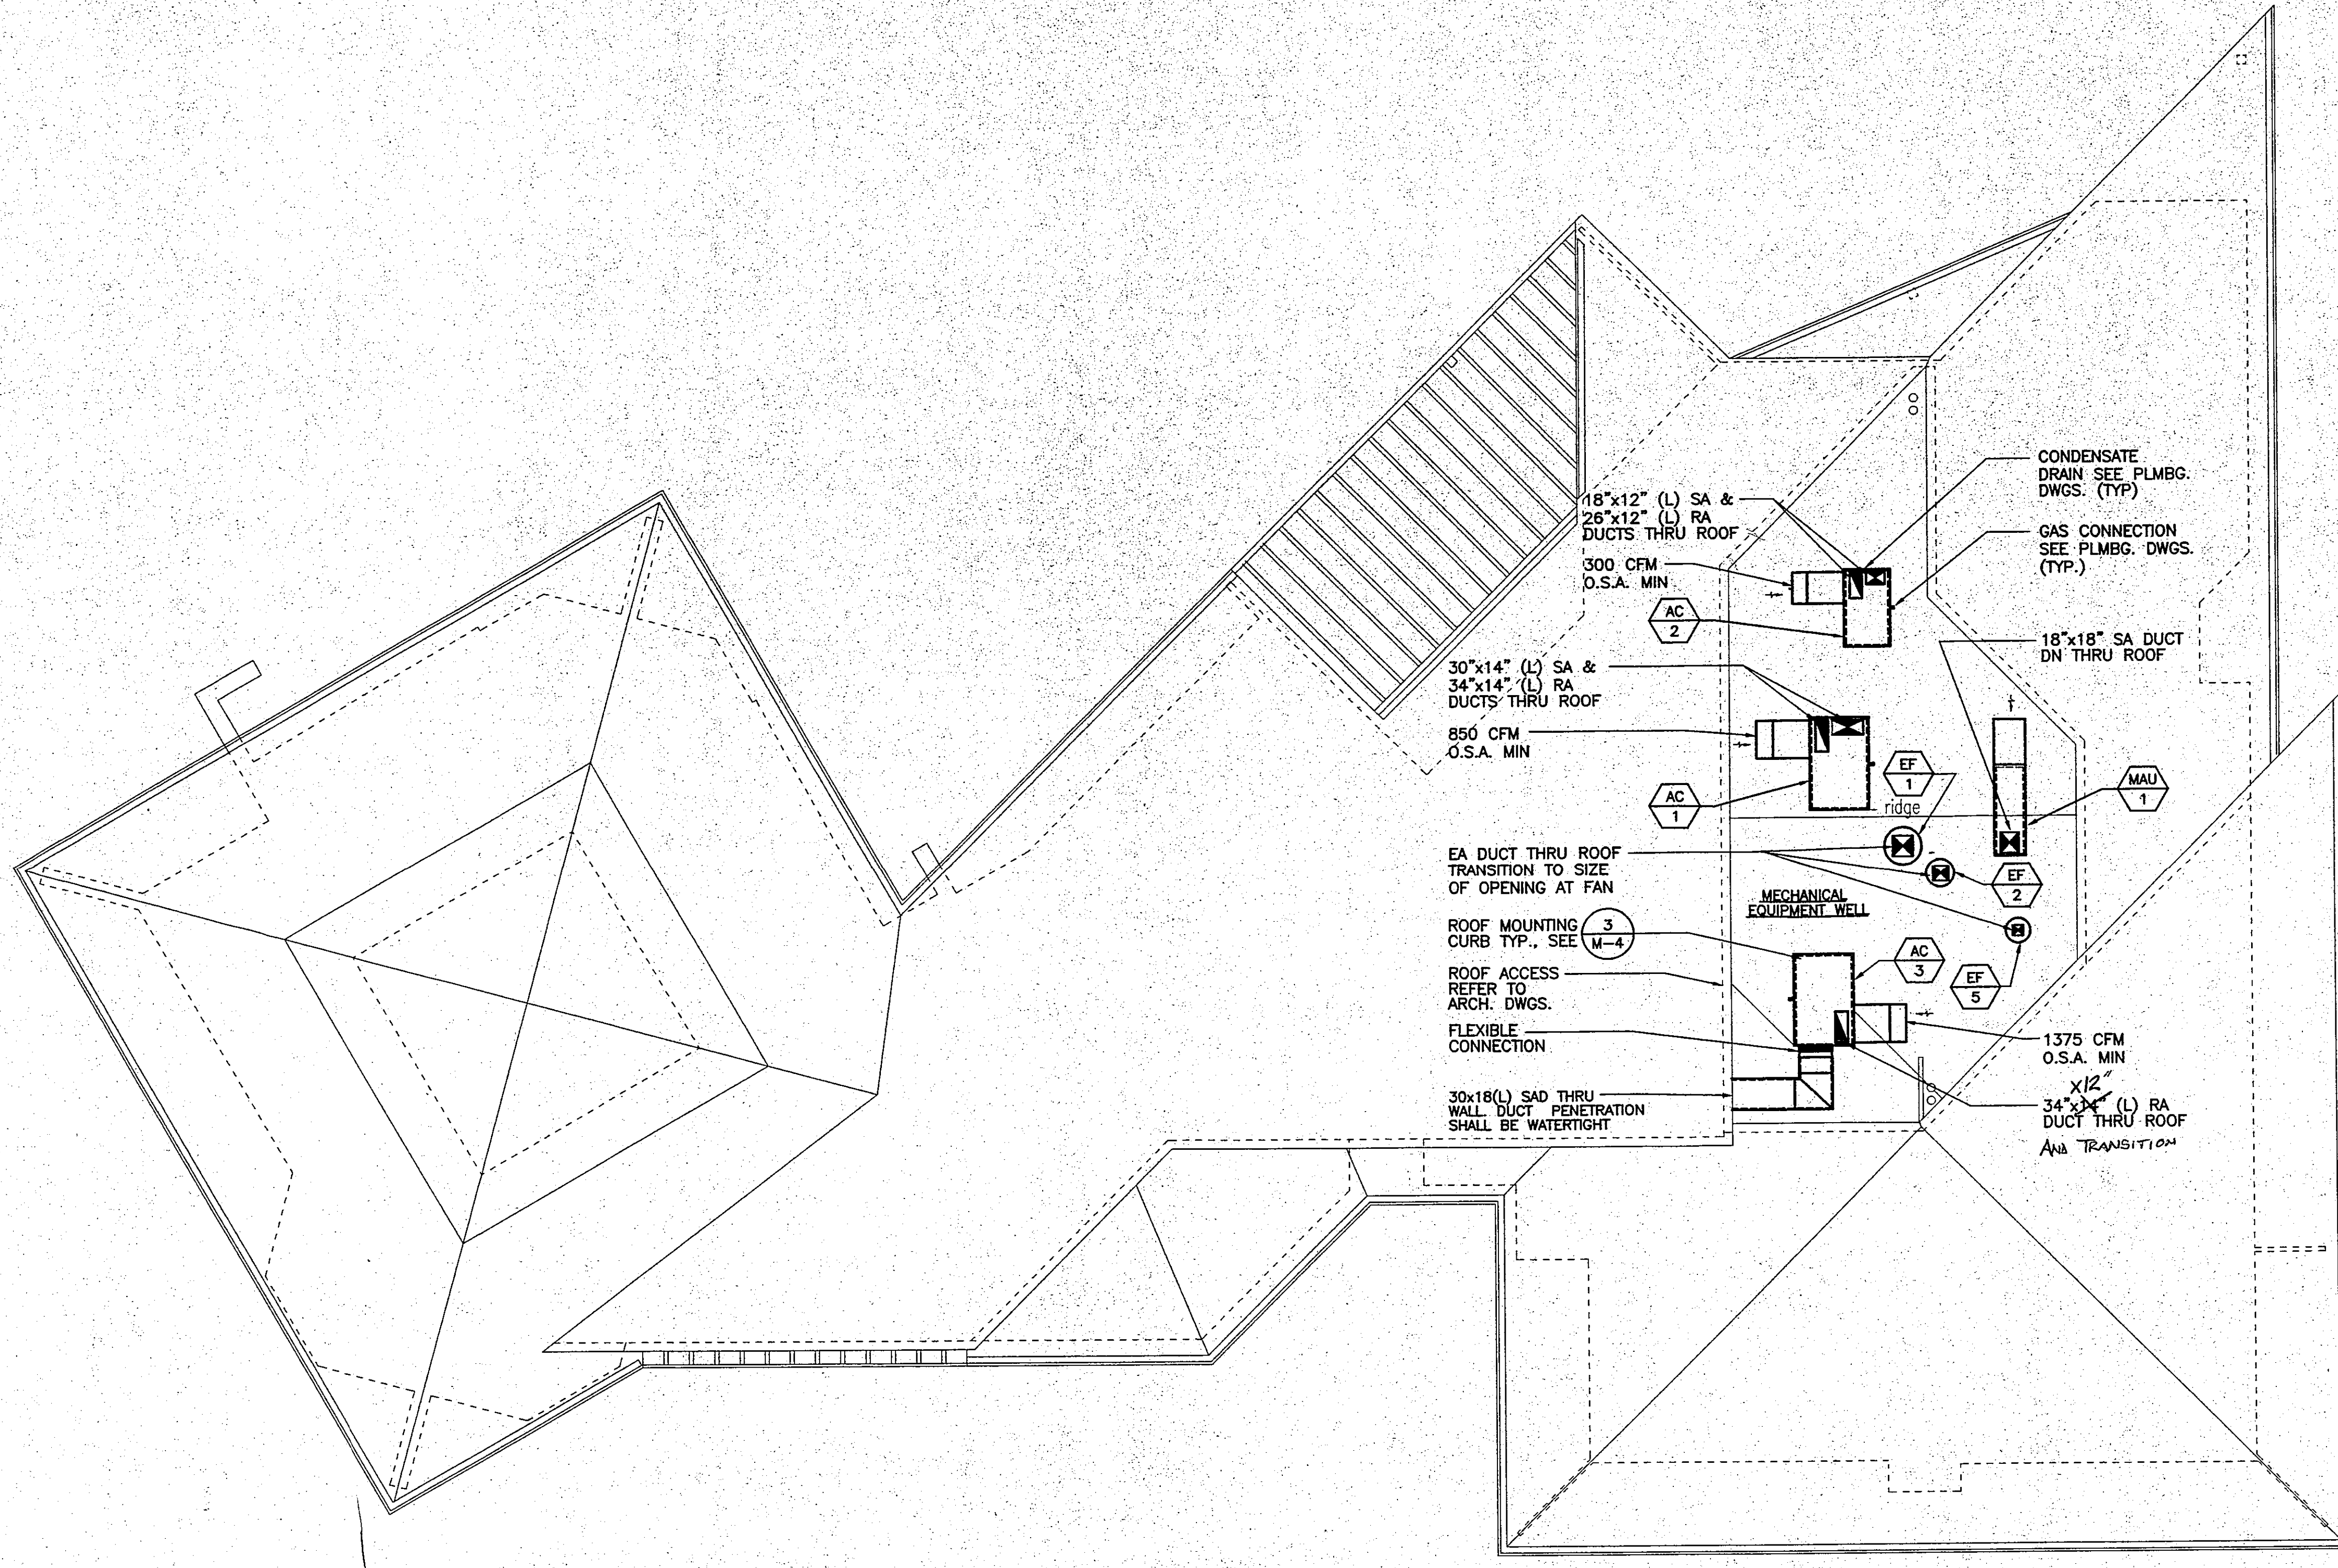

- NOTES:
- COORDINATE WITH ARCHITECTURAL & STRUCTURAL DRAWINGS EXACT LOCATIONS OF ALL ROOF MOUNTED EQUIPMENT.
 - PER CALIFORNIA TITLE-24 SECTION 121, THE VENTILATION RATES INDICATED ARE BASED UPON THE GREATER OF:
a. EXHAUST FLOWRATE + 5% OF THE SUPPLY AIR QUANTITY, OR
b. 15 CFM PER PERSON, OR
c. 0.15 CFM PER SQUARE FOOT.
 - FOR EQUIPMENT ATTACHMENT TO ROOF STRUCTURE, SEE DETAILS 1, 2, AND 5, SHEET M-4.

APPROVALS
Architect

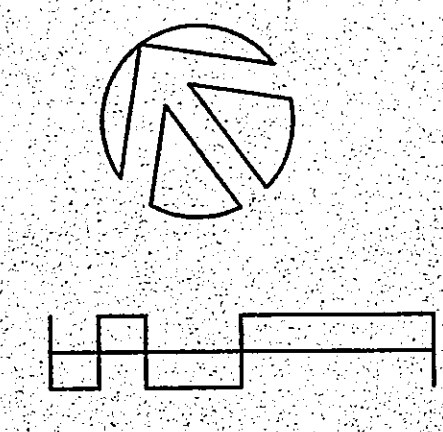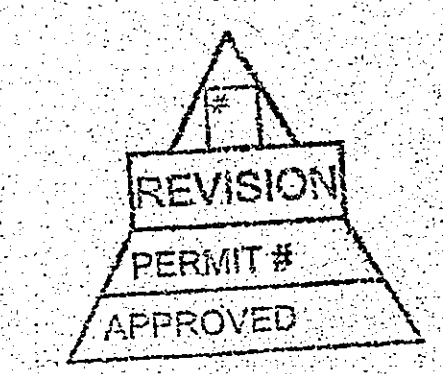


MECHANICAL ROOF PLAN

SCALE
1/8" = 1'-0"


1

RON YEO, FALA ARCHITECT, INC.
500 JASMIN AVENUE, CORONA, DEL. 19024
CALIFORNIA 92625 P: 954-644-8111 F: 954-644-0419
PATRICIA WARD, AIA, LE, ASSOCIATE ARCHITECT

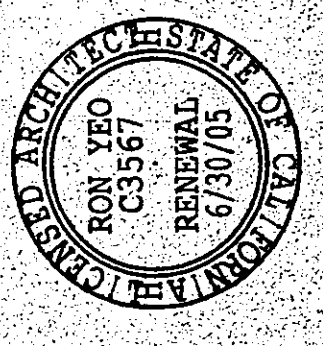

FTA
FALA ARCHITECT, INC.
500 JASMIN AVENUE
CORONA, DEL. 19024
P: 954-644-8111
F: 954-644-0419

PLANS PREPARED BY:

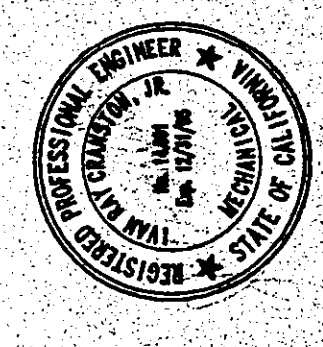

POINT VICENTE INTERPRETIVE
CENTER EXPANSION
31501 Palco Verde Drive, West
Rancho Palos Verdes, CA

Mechanical
Roof Plan

REVISION DATE: 02-09-04

THIS DRAWING IS NOT COMPLETE WITHOUT COMMENTS FOR CONSTRUCTION DATA

DRAWN DSM	CHECKED DSM
DATE 2/7/99	SCALE 1/8" = 1'-0"
SHEET # 97-123	SHEET CBM
M-3	
60 OF 69 SHEETS	