



PLUMBING LEGEND & SYMBOLS			
WASTE	DOMESTIC WATER	DOMESTIC HOT WATER	FUEL GAS
VENT LINE	CLEAN OUT - FLOOR	FLOOR DRAIN	FLOOR SINK
GATE VALVE	PLUG VALVE	CLEAN OUT - WALL	HOSE BIB
FIRE SPRINKLER			
SECTION IDENTIFICATION	SHEET NO.	ITEM IDENTIFICATION	SHEET NO.
W - WASTE	DW - DOMESTIC WATER	HW - DOMESTIC HOT WATER	DF - DRINKING FOUNTAIN
VTR - VENT TO ROOF	CO - CLEAN OUT	FD - FLOOR DRAIN	FS - FLOOR SINK
LAV - LAVATORY	WC - WATER CLOSET	G - FUEL GAS	U - URINAL
SOV - SHUT OFF VALVE	YB - YARD BOX	CLG - CEILING	DN - DOWN
MH - MANHOLE			

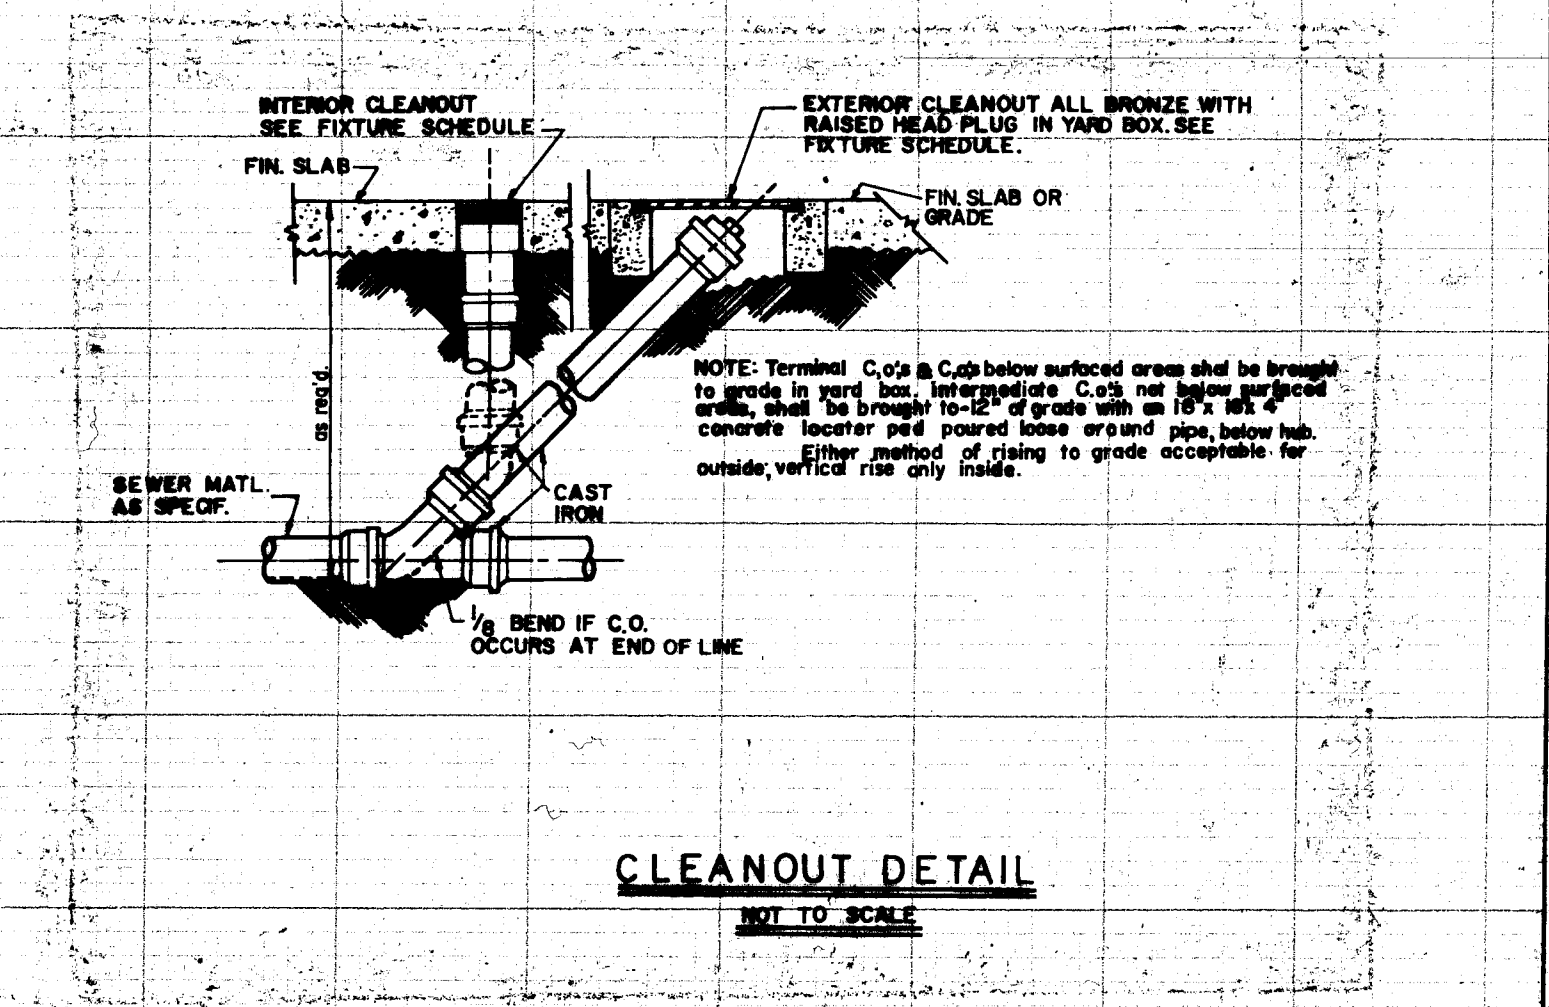

PLUMBING FIXTURE SCHEDULE					
MARK	WASTE	VENT	CW	HW	COMMENTS
WC-1	4"	2"	1 1/2"	—	1" FLUSH VALVE
U-1	2"	1 1/2"	3/4"	—	3/4" FLUSH VALVE
L-1	2"	1 1/2"	1"	—	
S-1	2"	1 1/2"	1"	1/2"	
SS-1	2"	1 1/2"	1"	—	
DF-1	2"	1 1/2"	3/4"	—	
DF-2	2"	1 1/2"	3/4"	—	
HB-1	—	—	3/4"	—	
FHC-1	—	—	2"	—	
FD-1	2"	—	—	—	
FS-1	2"	—	—	—	

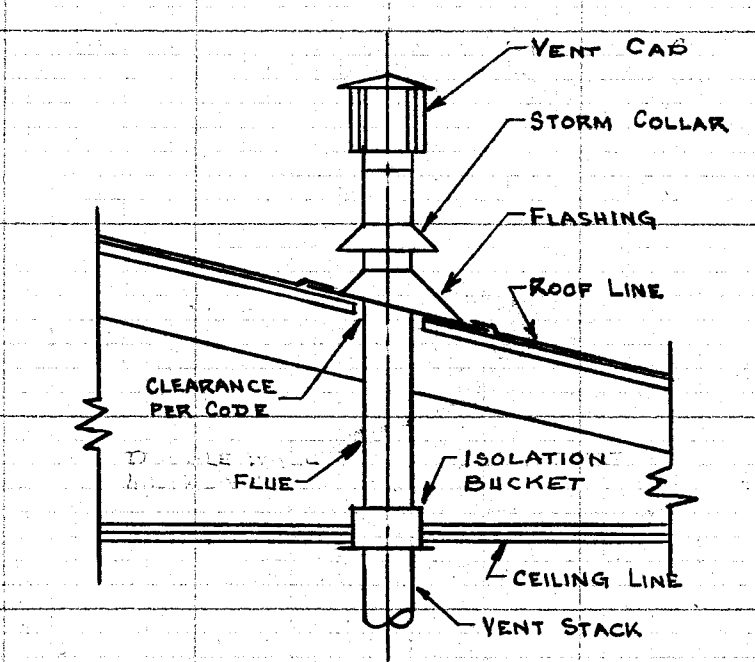

NOTES
CLEANOUTS SHALL COMPLY WITH SECTIONS 406 & 1107 OF THE LOS ANGELES COUNTY PLUMBING CODE.

TABLE OF UTILITIES	
CW DEMAND	DOMESTIC = 90 GPM LAWN SPRINKLER = 135 GPM TOTAL = 225 GPM
GAS	HEATING = 120 CFH COOKING = 75 CFH HOT WATER = 27 CFH
WASTE	64 FIXTURE UNITS

HOT WATER HEATER SCHEDULE					
MARK	DESCRIPTION	TYPE	BTU INPUT	CAPACITY	RECOVERY - GPH
HWH-1	WATER HEATER	GAS FIRED	36,000	30 GALLON	35.2

HEATER SCHEDULE						
MARK	DESCRIPTION	TYPE	BTU INPUT	BTU OUTPUT	HP	CFM
H-1	WALL FURNACE	FORCED AIR	60,000	45,000	1/20	400

8.2V. Pack
Mechanical Floor Plan Sheet M of 3

