

# PALOS VERDES COUNTY PARK

PALOS VERDES

CALIFORNIA

EDWIN H. RIPPERDAN A.I.A. ARCHITECT - 3610 LONG BEACH BLVD.

LONG BEACH, CALIFORNIA

## INDEX OF DRAWINGS


SHEET NO.	SHEET TITLE
<b>ARCHITECTURAL &amp; STRUCTURAL</b>	
A-1	INDEX SHEET
A-2R	SITE DEVELOPMENT PLAN
A-3R	SITE GRADING PLAN (PART 1)
A-4R	SITE GRADING PLAN (PART 2)
A-5	DETAIL PLAN OF PLAY AREAS, HARDCOURT & ETC.
A-6	FOUNDATION PLAN & DETAILS
A-7R	FLOOR & ROOF PLAN
A-8	FINISH, DOOR, WINDOW SCHEDULE & DETAILS
A-9R	FRAMING PLAN & DETAILS
A-10	DETAILS
A-11	ELEVATIONS & SECTIONS
A-12	INTERIOR ELEVATIONS & CABINET DETAILS
A-13	MISCELLANEOUS PLAYGROUND EQUIPMENT DETAILS
A-14	SERVICE BUILDING PLANS, ELEVATIONS & DETAILS
<b>ELECTRICAL</b>	
E-1	ELECTRICAL SITE PLAN
E-2	ELECTRICAL FLOOR PLAN
<b>MECHANICAL</b>	
M-1	MECHANICAL FLOOR PLAN
M-2R	MECHANICAL SITE PLAN
M-3R	DRAIN & SEWER PLAN & PROFILE
<b>SPRINKLER</b>	
S-1	AUTOMATIC SPRINKLER PLAN
<b>LANDSCAPE</b>	
L-1R	LANDSCAPING PLAN
L-2R	LANDSCAPING SCHEDULE
X-1 & X-2	SUPPLEMENTAL DRAWINGS (SPRINKLER WORK)

## GENERAL NOTES

- THE CONTRACTOR SHALL VERIFY ALL CONDITIONS, DIMENSIONS & ELEVATIONS ON JOB SITE.
- PROVIDE CONSTRUCTION FENCE AROUND SITE IN MANNER & TYPE APPROVED BY THE ARCHITECT.
- MAINTAIN ALL ADJACENT AREAS & STREETS OUTSIDE THE SITE FREE & CLEAR OF ALL OBSTRUCTIONS.
- FOR TYPE, GRADE, QUALITY & INSTALLATION OF ALL MATERIALS REFER TO DRAWINGS AND / OR SPECIFICATIONS.
- REQUIRED FIRE EXTINGUISHERS FURNISHED & INSTALLED BY LOS ANGELES COUNTY. SEE SHT. A-8 FOR STANDARD ABBREVIATIONS.

## LEGEND

- N.G. NATURAL GRADE
- F.G. FINISH GRADE
- I.P. TOP OF PAVING
- T.C. TOP OF CURB
- F.L. FLOW LINE
- F.F. FINISH FLOOR
- INV. EL. INVERT ELEVATION

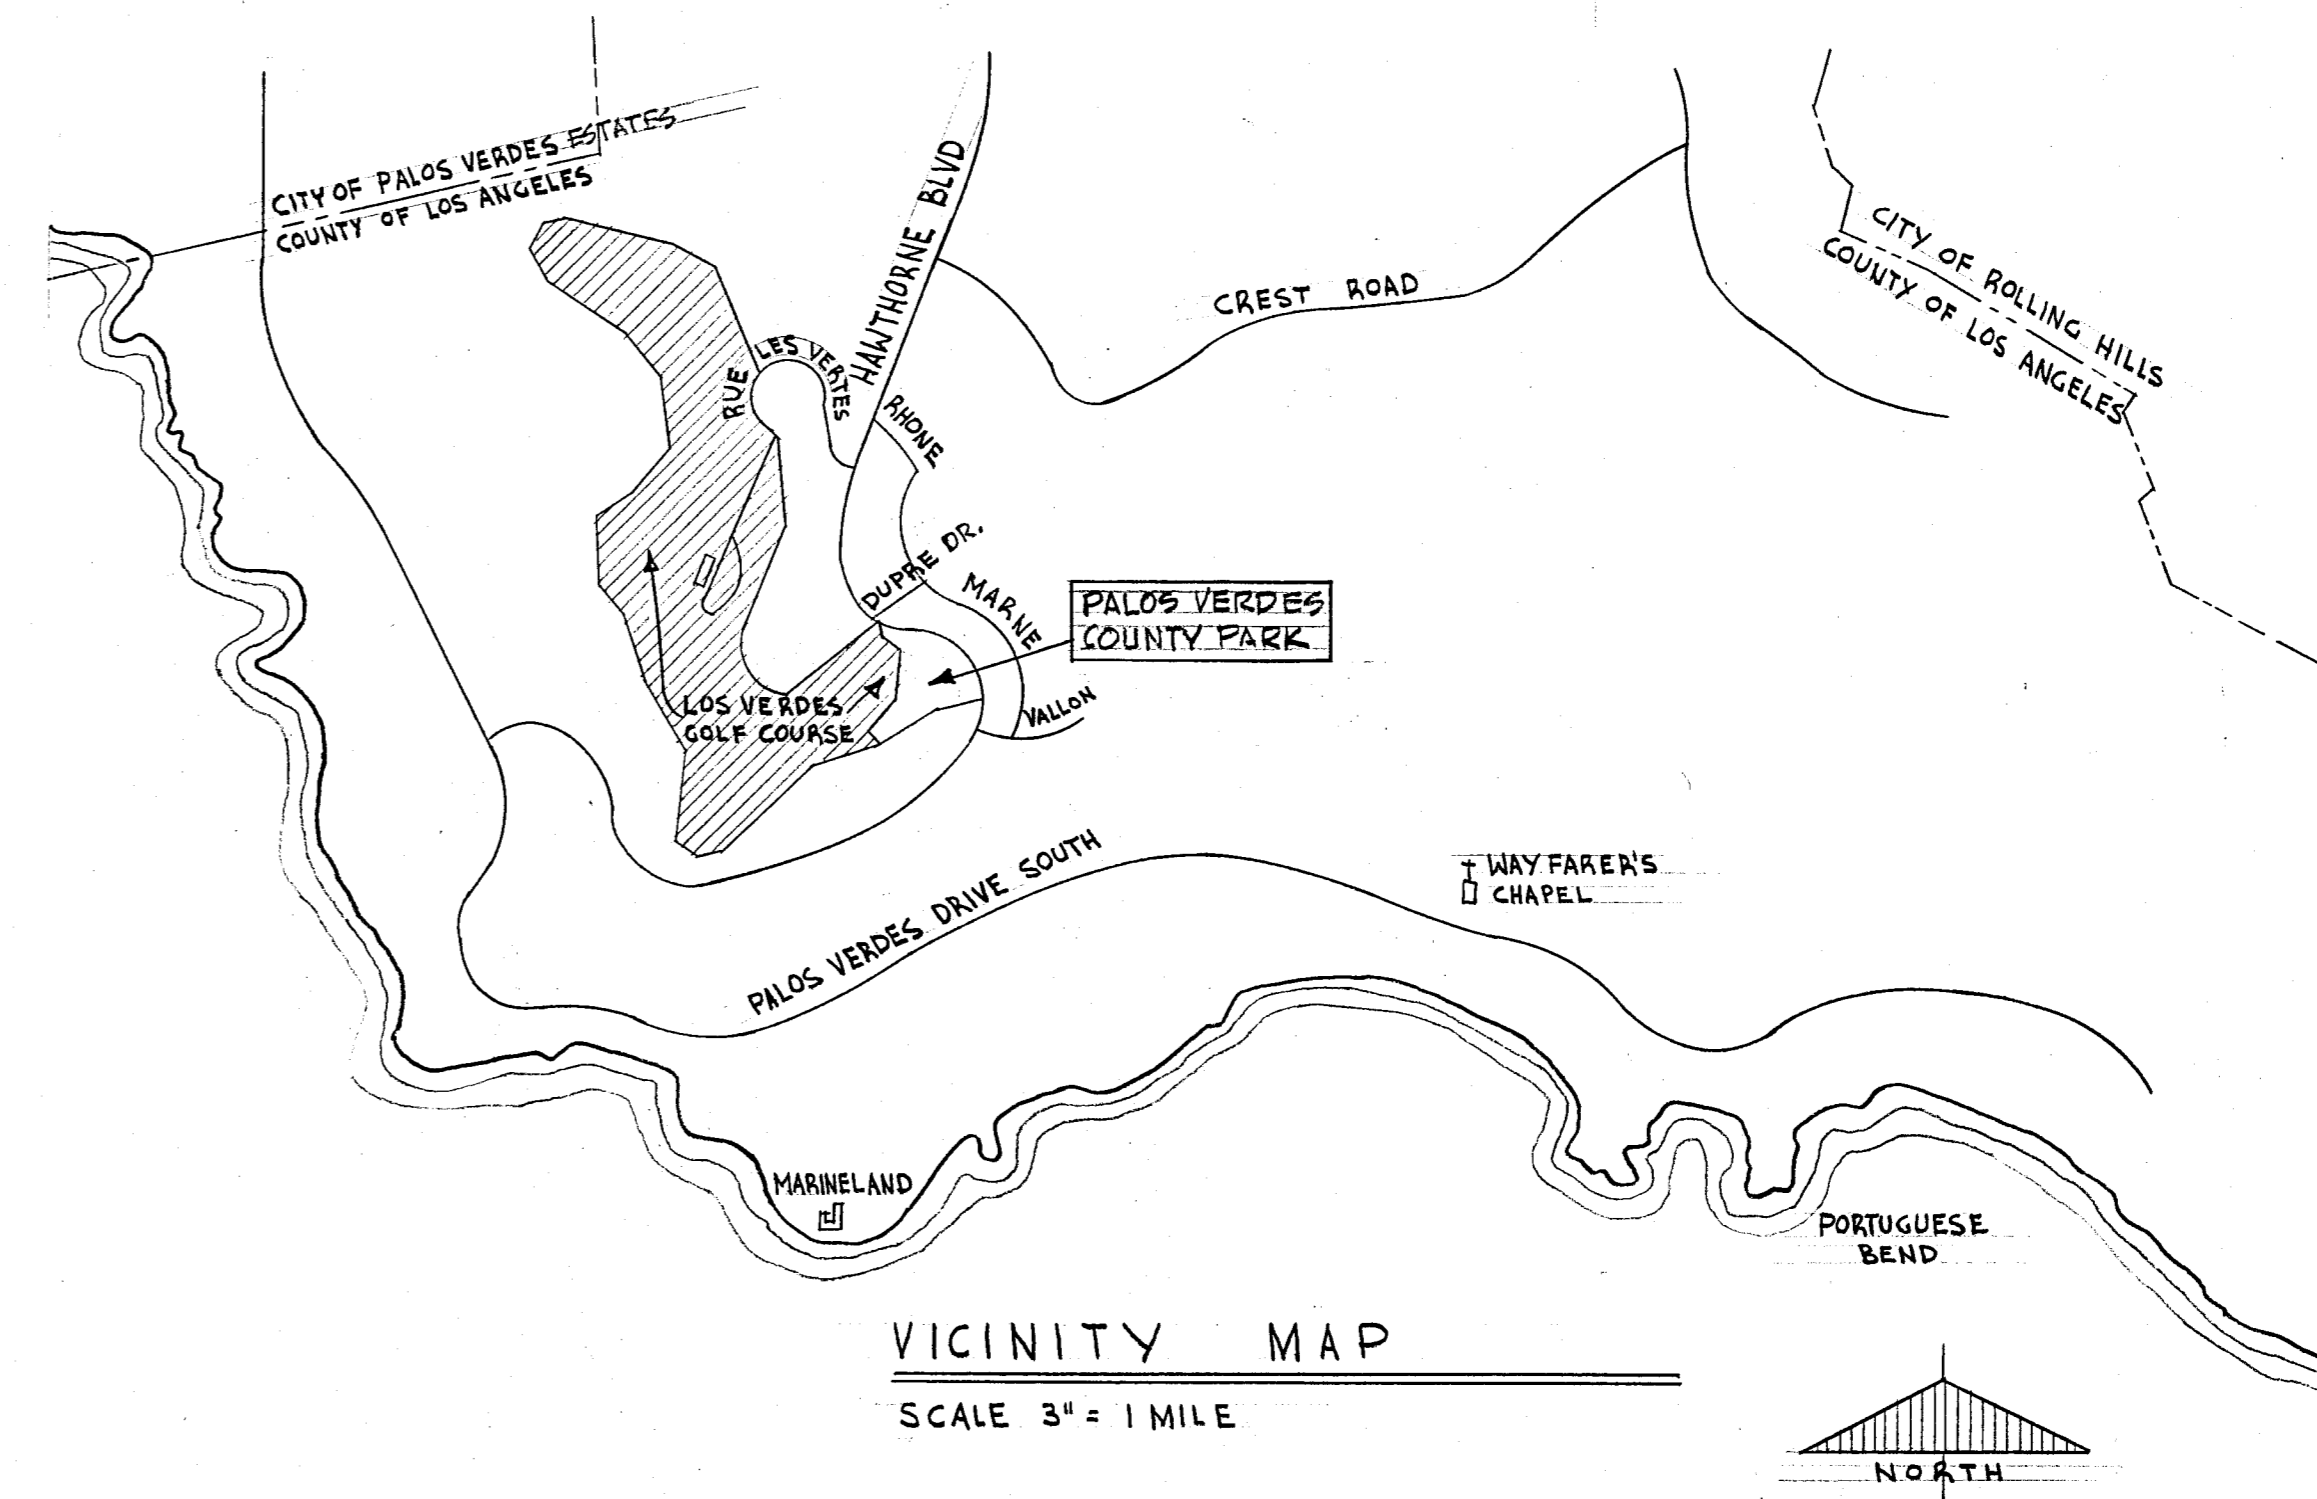

*Edwin H. Ripperdan*  
ARCHITECT C-2307  
STATE REG. NO.

APPROVED BY:  
*W. Johnson by R. J. Page*  
DIRECTOR OF PARKS DATE 6-29-65  
*William E. ...*  
DIRECTOR OF COMMUNICATIONS DATE

ACTIVITY BUILDING & GENERAL DEVELOPMENT FOR THE COUNTY OF LOS ANGELES SHEET  
**PALOS VERDES COUNTY PARK** AI  
30359 S. HANTHORNE BLVD, PALOS VERDES, CALIF.  
26 BUILT REVISIONS MADE 2/27/70 E.H.R. SPEC. NO. 2399 CAP. PROJECT NO. 885902 OF 14

AS BUILT

EAST FILE CORP. IRVINE, CA  
 HANGER EPHED  
 120  
 Sheet #1 of 14  
 R.P.V. Park  
 Title Sheet